


THIS DOCUMENT AND ITS CONTENTS ARE THE EXCLUSIVE PROPERTY OF JCS CONTROLS, INC. AND MUST NOT BE REPRODUCED, TRANSMITTED, OR COMMUNICATED WITHOUT PRIOR WRITTEN APPROVAL OF JCS CONTROLS, INC. THESE PLANS ARE NOT MADE FOR CONSTRUCTION OR INSTALLATION UNLESS USE FOR THIS PURPOSE HAS BEEN EXPRESSLY APPROVED BY JCS CONTROLS, INC. ON THIS DOCUMENT. DWG NAME: 2871-010 (03/17/11). DWG JOB# 2871 DIR MOD. TIME: 3/17/2011 11:14 AM

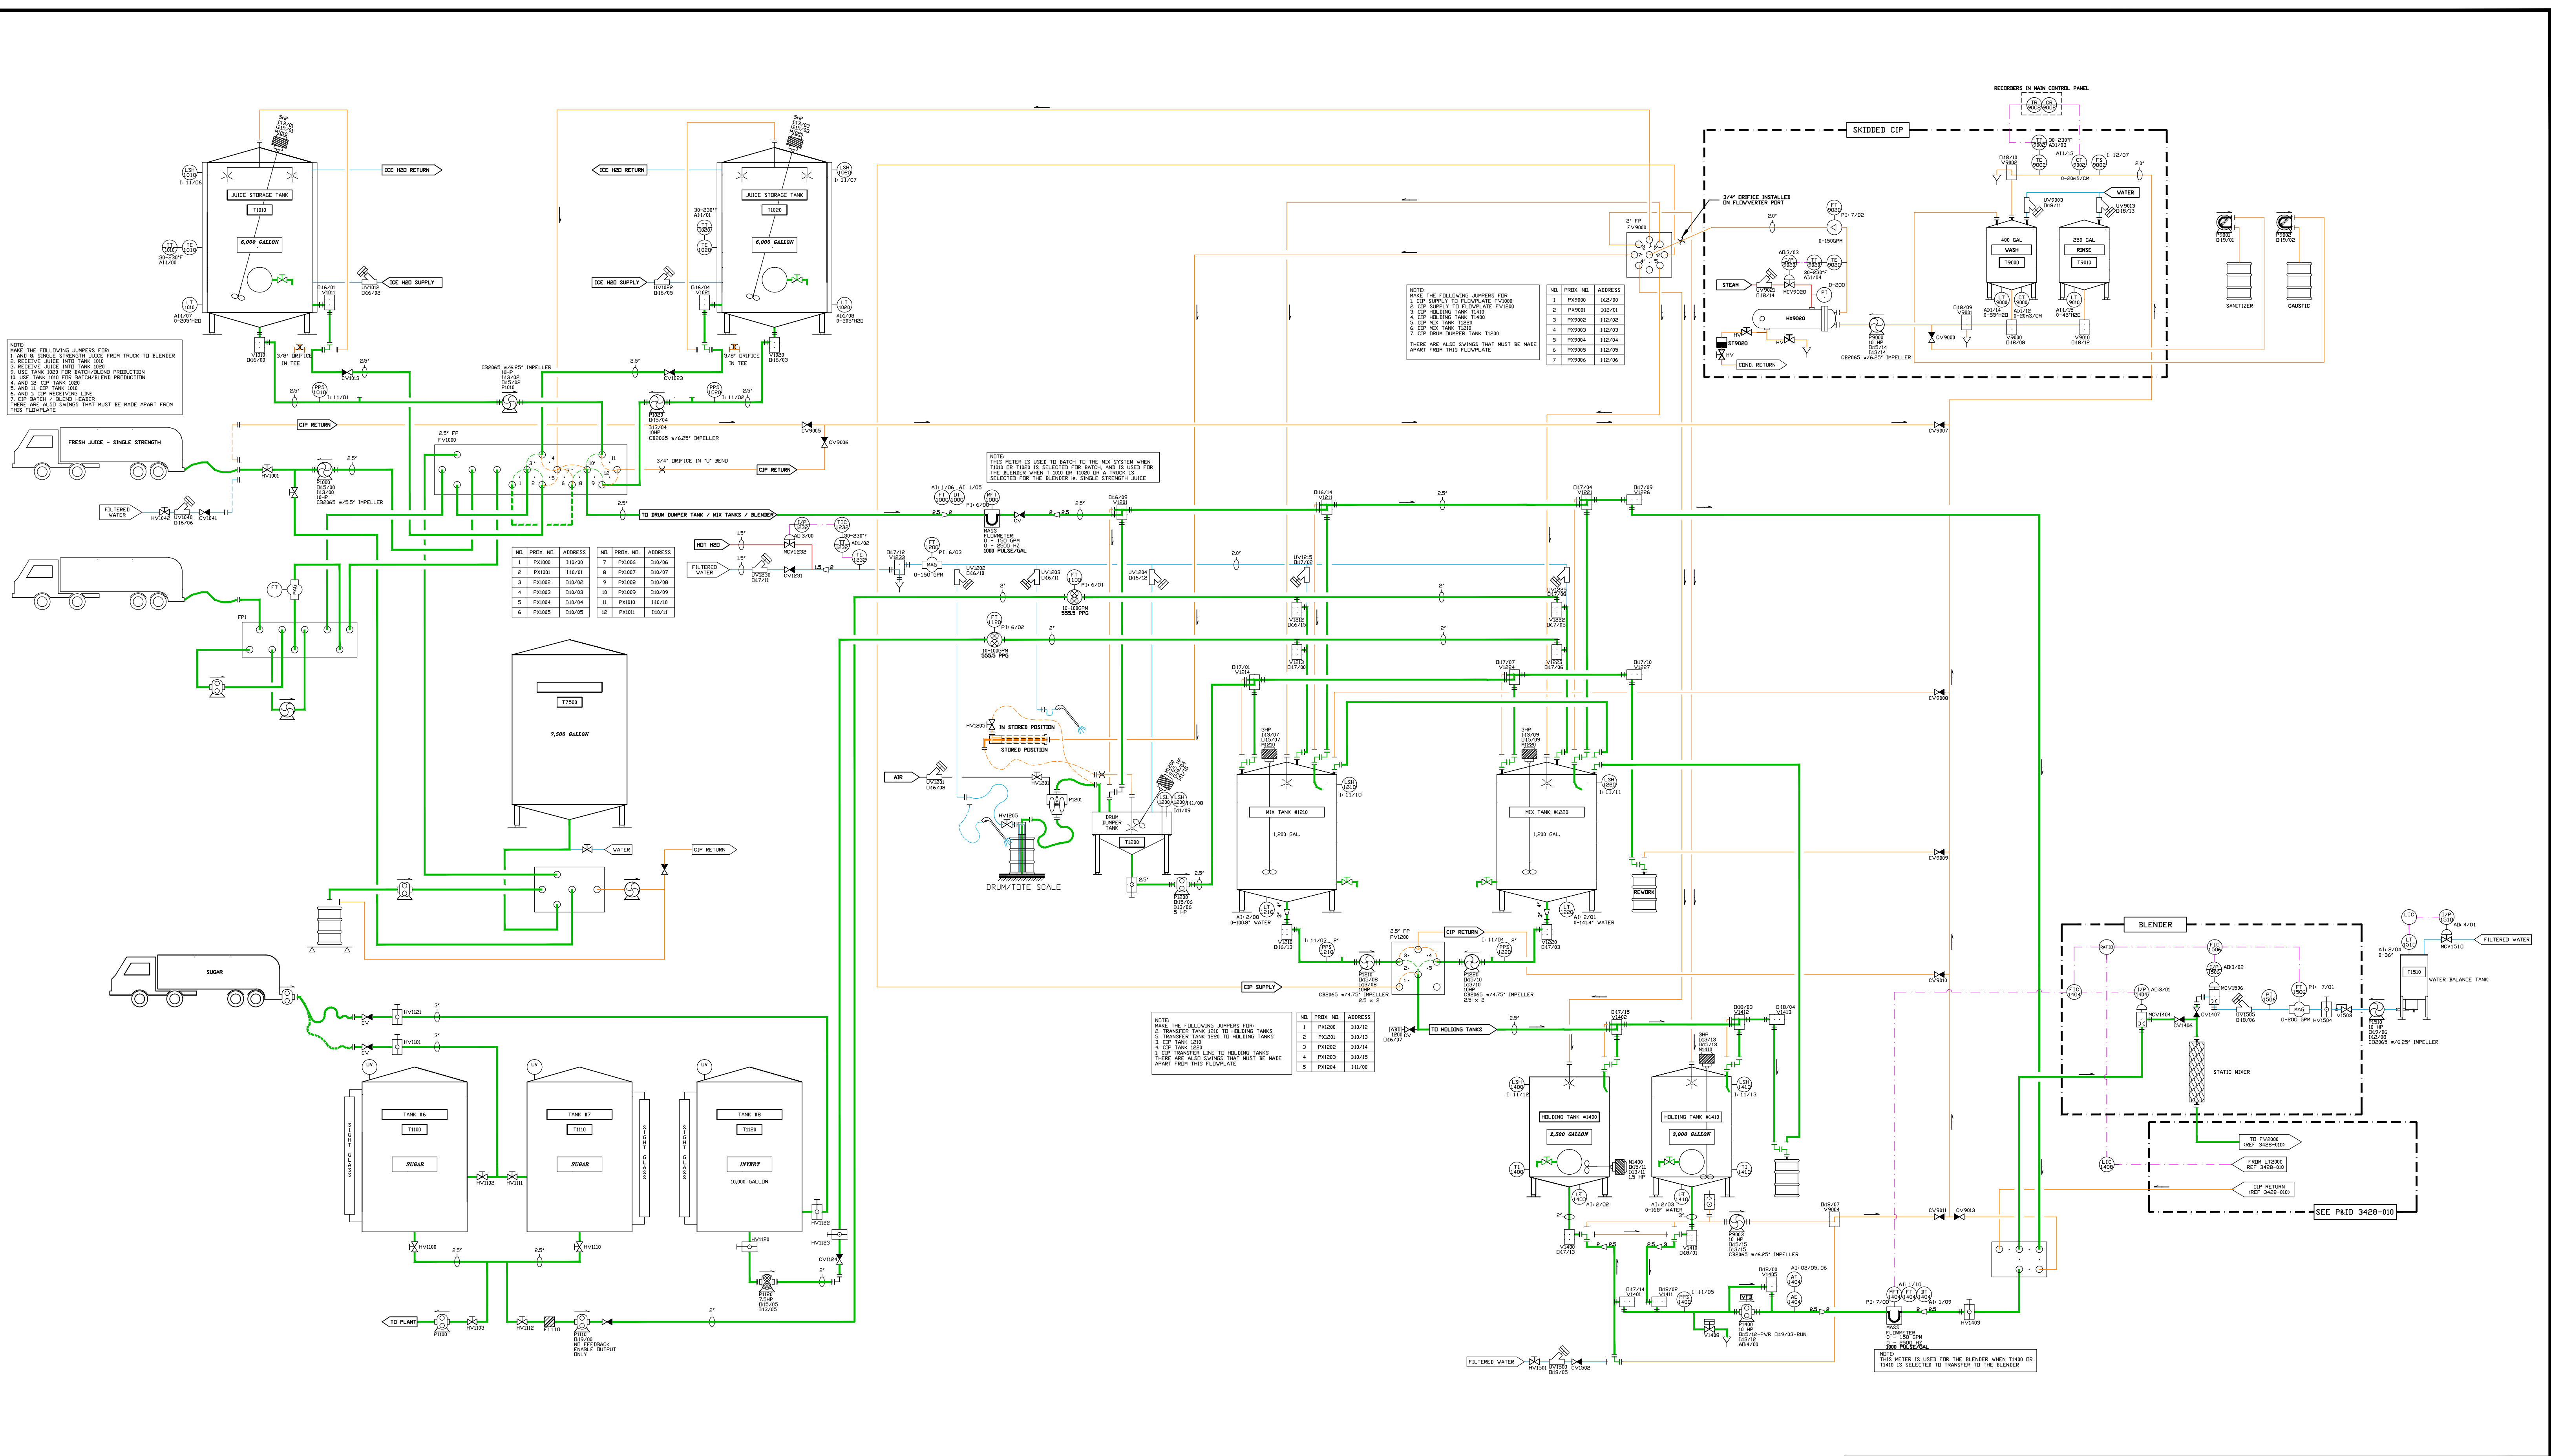

PROCESS & INSTRUMENTATION LEGEND	
	EQUIPMENT
	SKID/PROCESS BOUNDARY
	CIP
	PROCESS
	COOL UTILITY
	HOT UTILITY
	SIGNAL

3/17/11	UPDATED DRAWING TO AS BUILT	CCK	RAV		
REV. DATE	DESCRIPTION	DRWN	PM	REV. DATE	DESCRIPTION
DPSG CARTERET, NEW JERSEY		CUSTOMER CODE		ROCHESTER, N.Y.	
P&ID JUICE BATCHING SYSTEM		SCALE		PROJECT NO. 2871	
PROCESS		DRAWN BY/PROJ. MANAGER		DATE	
BATCHING		CCK RPF		1/15/03	
				2871-010	



Process & Control Systems Engineering